


SAMPLE UNIVERSAL DESIGN SITE PLAN FOR TAX CREDIT RESERVATION APPLICATION


NOTE: THESE PRINTS HAVE BEEN SCALED TO FIT THIS PAPER SIZE

DATE LAST MODIFIED:
 10.20.2016



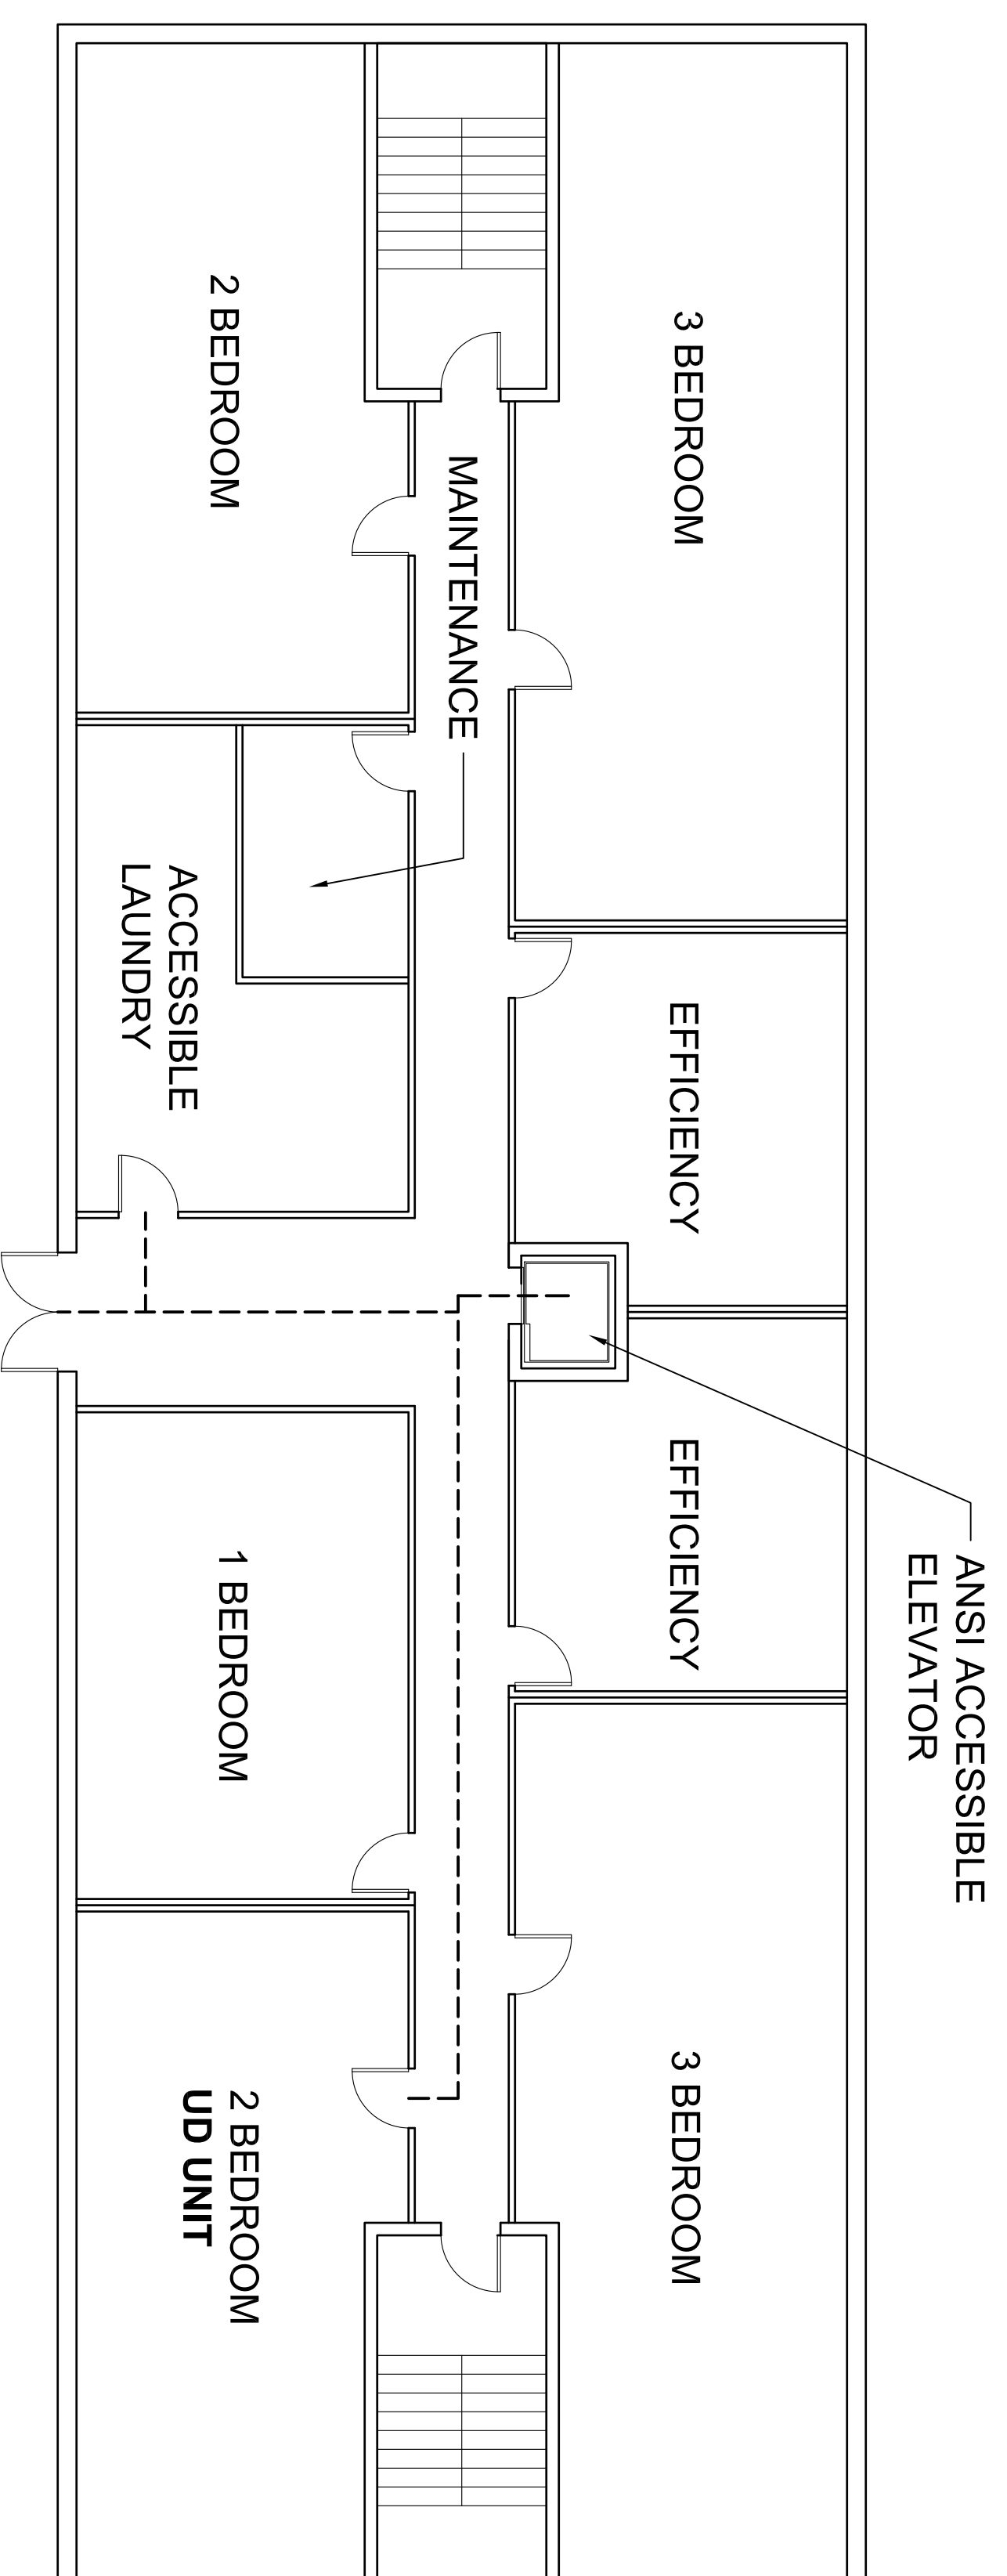

UNIVERSAL DESIGN BUILDING PLAN - BLDG. 3, 1ST FLOOR
 SCALE: 1/8"=1'-0"

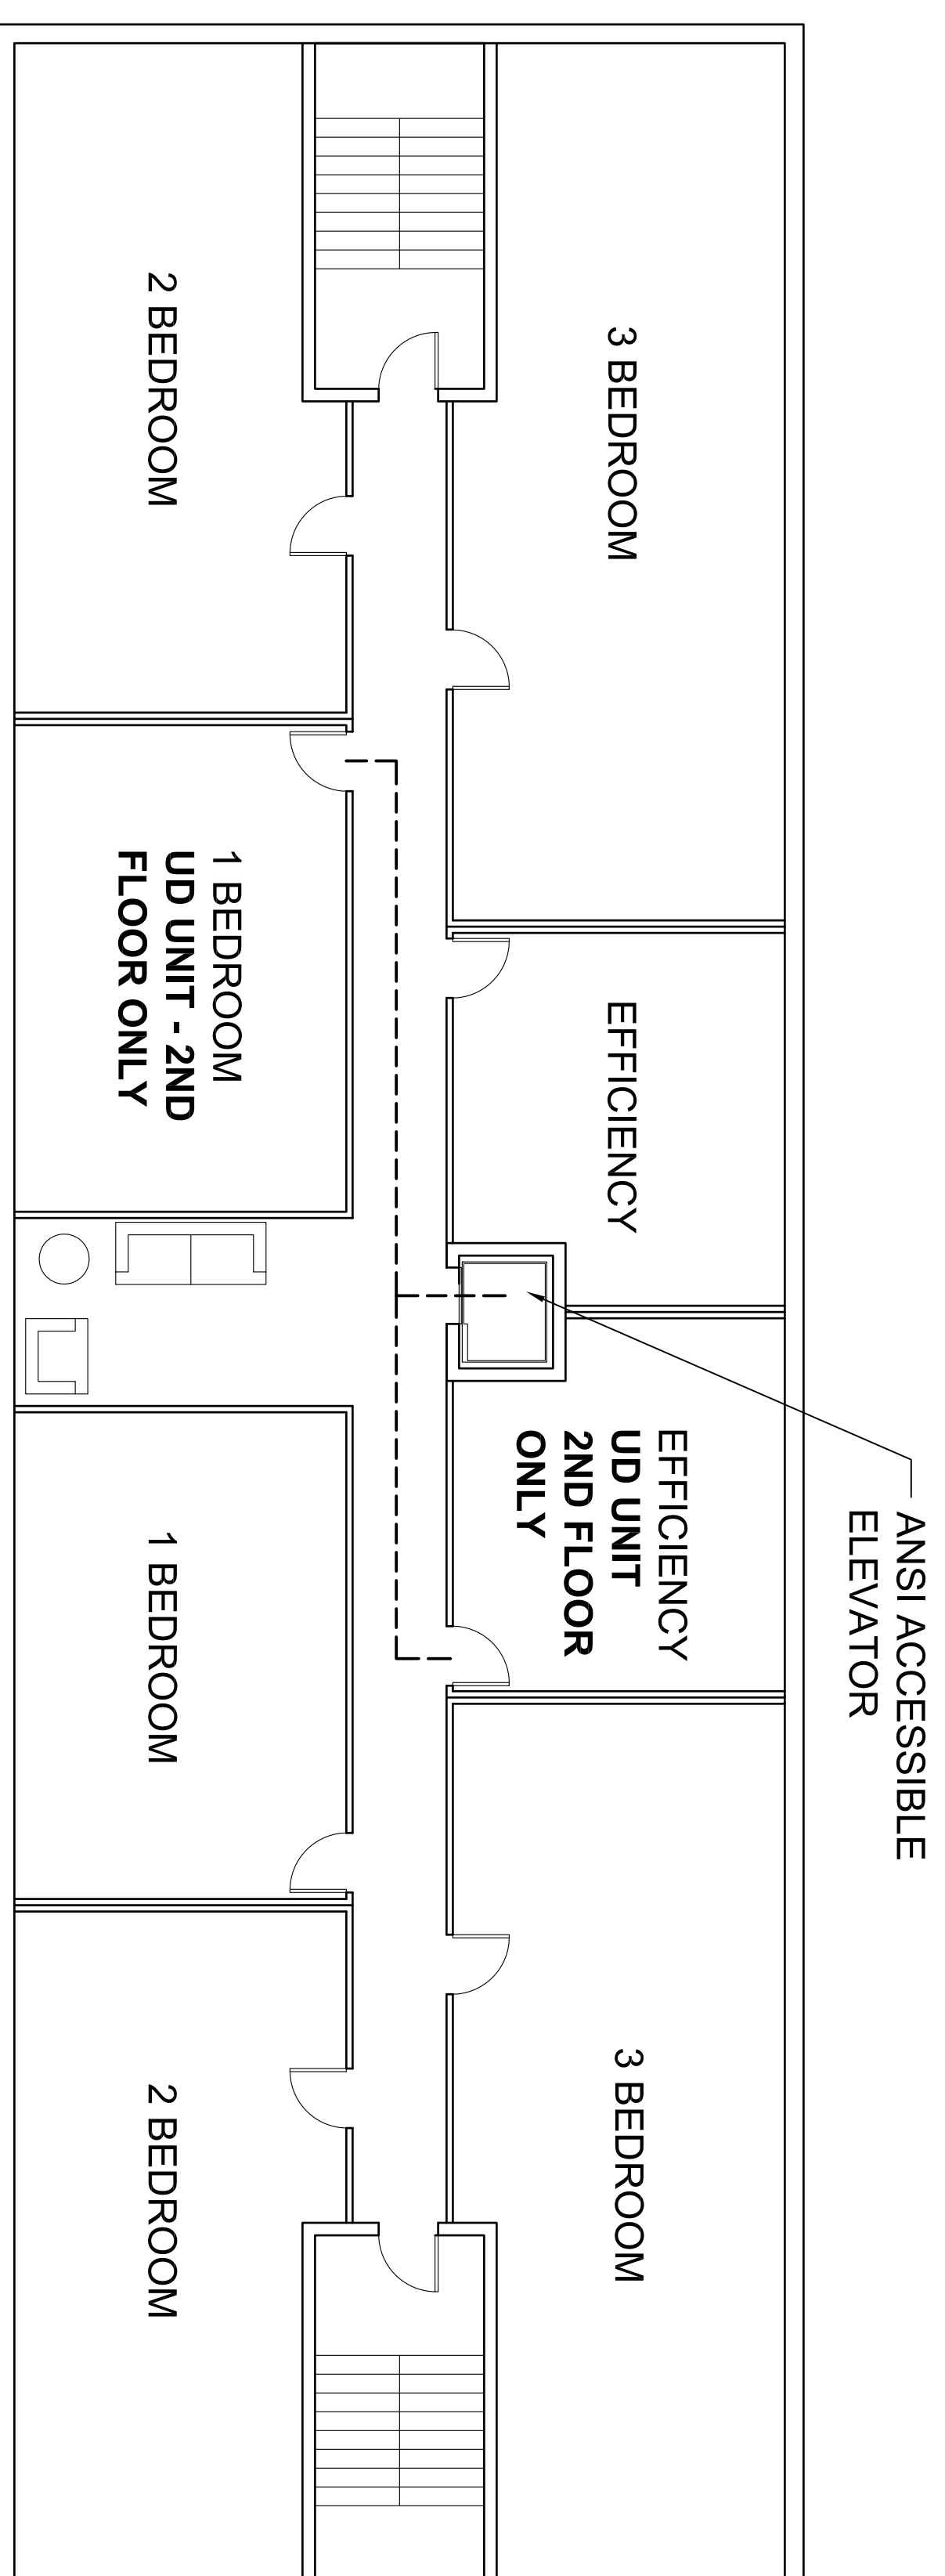

UNIVERSAL DESIGN BUILDING PLAN - BLDG. 3, 2ND - 4TH FLOOR SIM.
 SCALE: 1/8"=1'-0"

LEGEND

 ACCESSIBLE ROUTE
 -MAX. RUNNING SLOPE 5%
 -MAX. CROSS SLOPE 2%


UNIVERSAL DESIGN GENERAL NOTES:
 -THREE U.D. UNITS IDENTIFIED ON PLANS
 -ONE UNIT ON FIRST FLOOR
 -TWO UNITS ON SECOND FLOOR

SAMPLE UNIVERSAL DESIGN BUILDING PLAN FOR TAX CREDIT RESERVATION APPLICATION

NOTE: ALL BUILDING TYPES WITH U.D. UNITS MUST BE PROVIDED
 NOTE: THESE PRINTS HAVE BEEN SCALED TO FIT THIS PAPER SIZE

VHDA


DATE LAST MODIFIED:
 10.20.2016

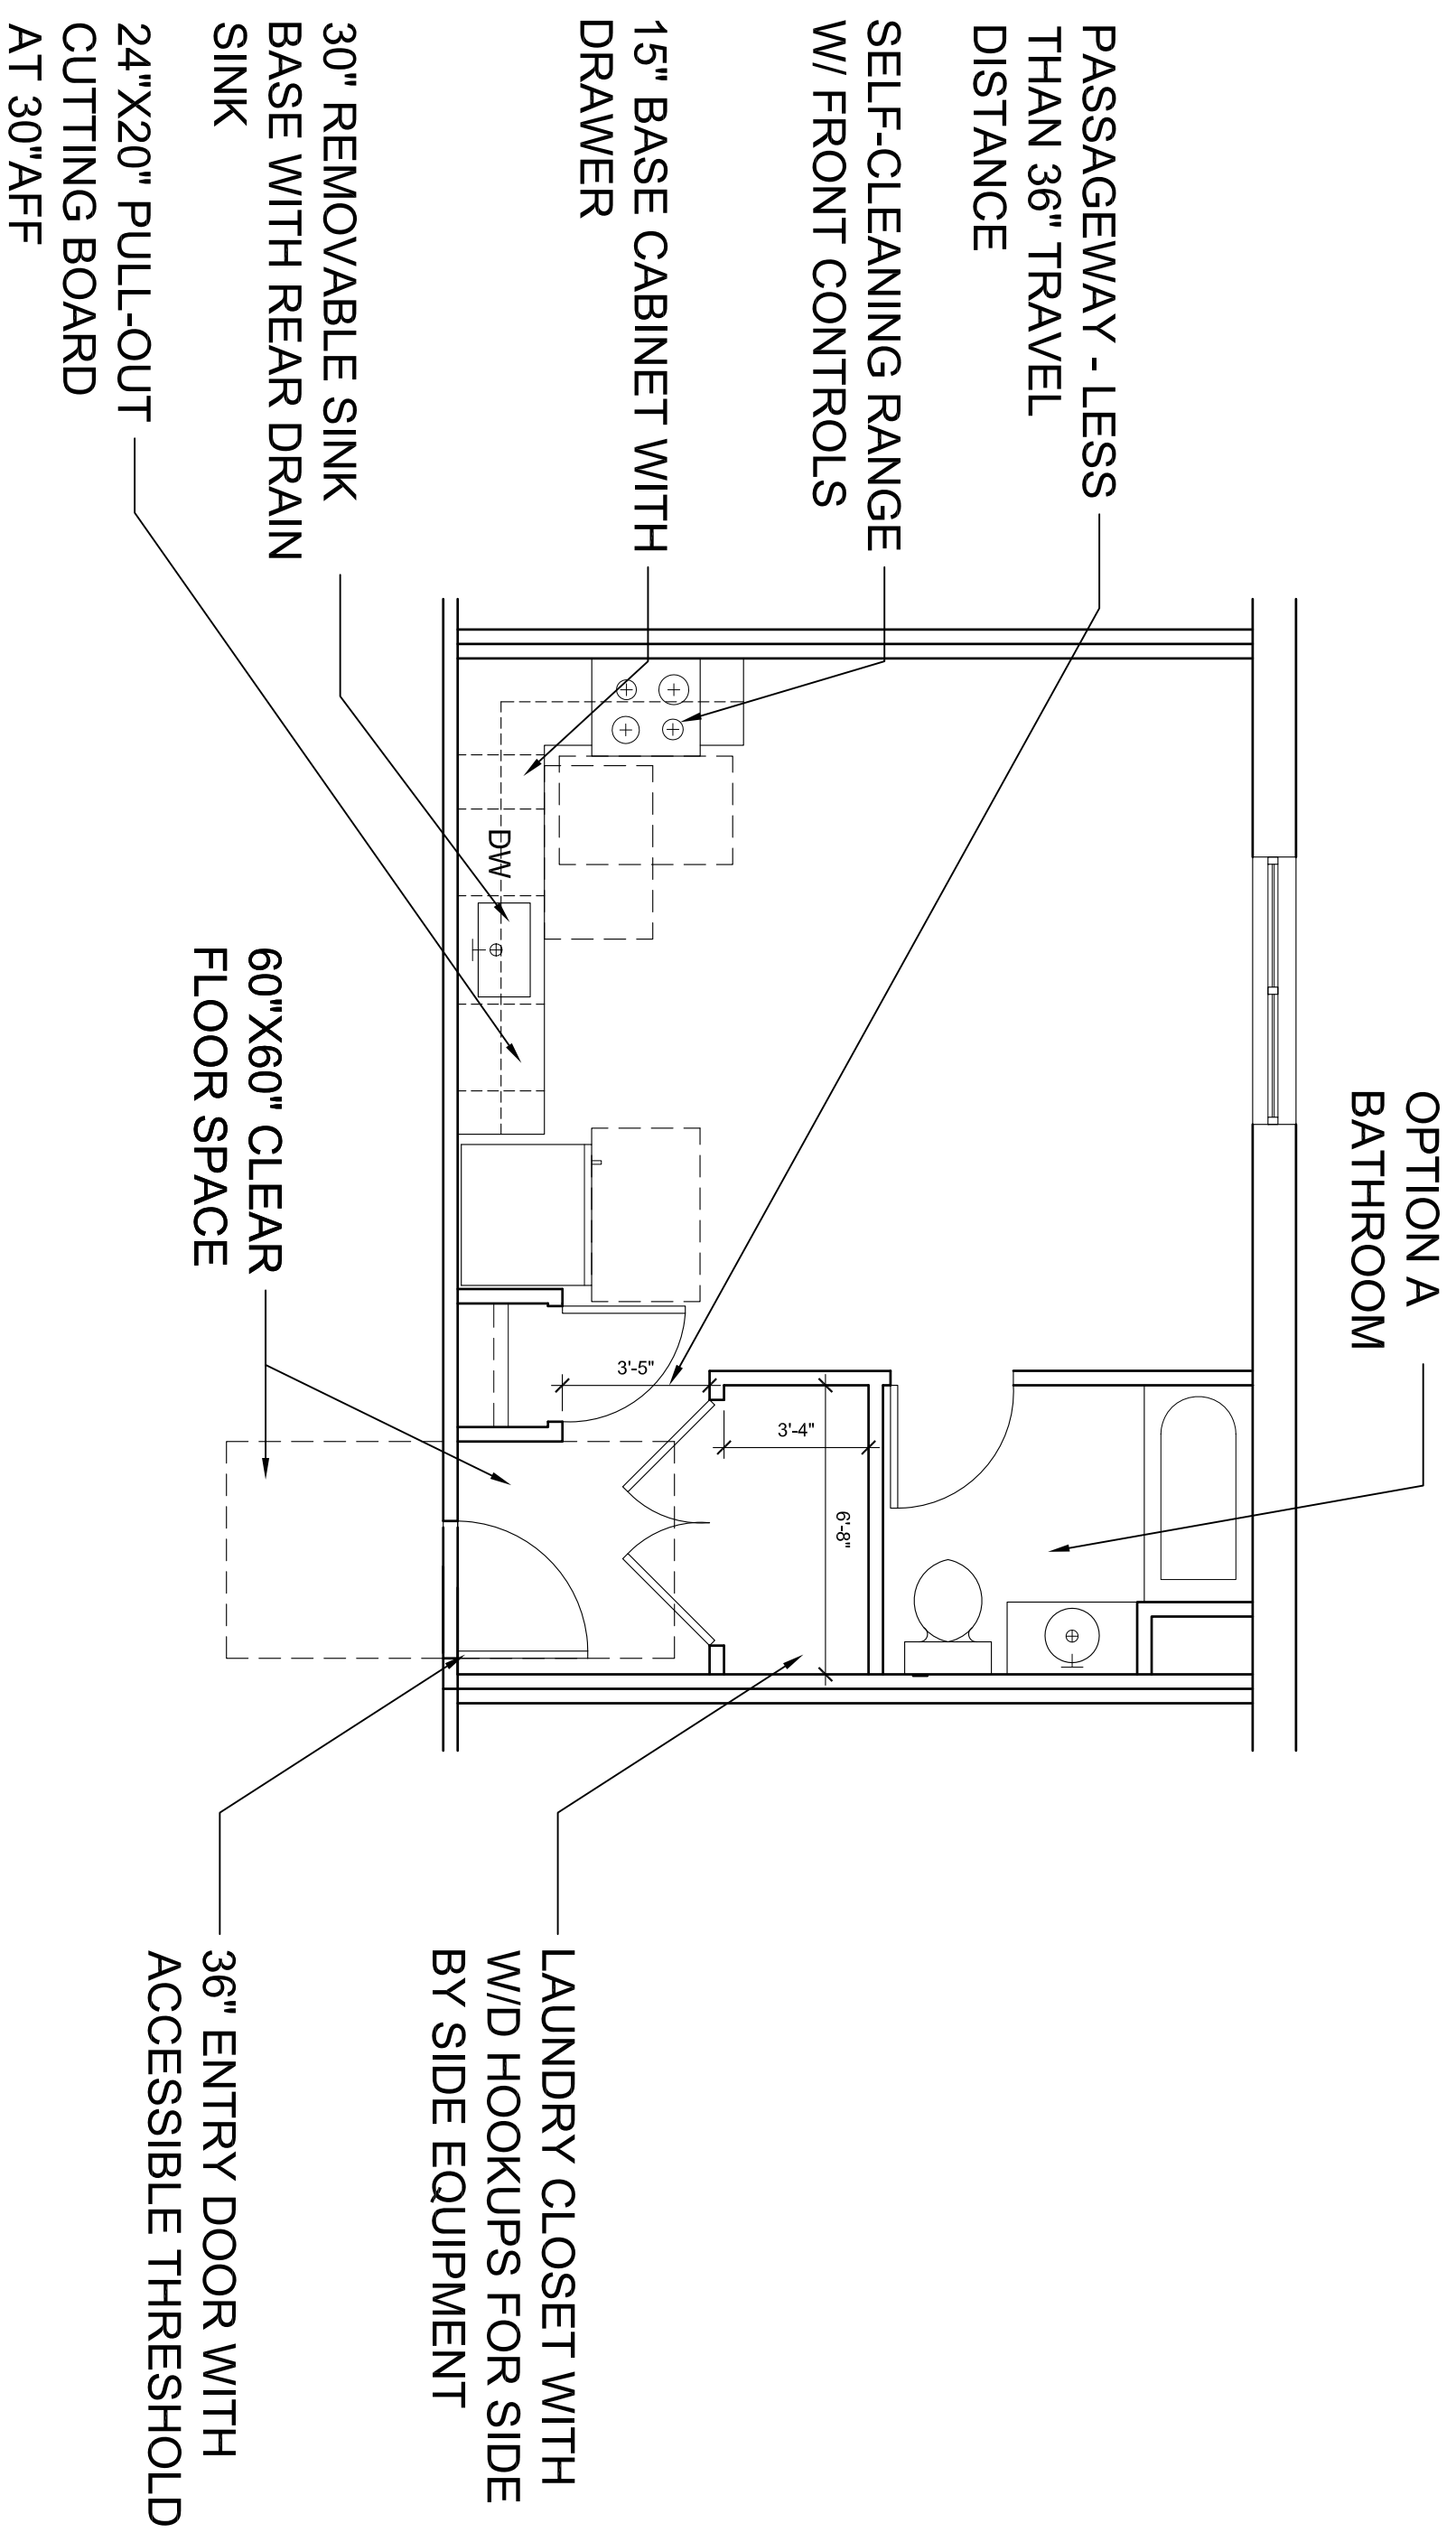

UNIVERSAL DESIGN UNIT PLAN - EFFICIENCY


SCALE: 1/4"=1'-0"

- UNIVERSAL DESIGN GENERAL NOTES:**
- ALL ESSENTIAL UD ELEMENTS IDENTIFIED ON PLANS
 - CLEAR FLOOR SPACE EXTENDS MIN. 18" PAST THE LATCH AT PULL SIDE OF ALL DOORS
 - CLEAR OPENING WIDTH IS NOT LESS THAN 32" AT PASSAGE DOORS
 - LEVER HANDLES AND PUSH BUTTON PROVIDED AT ALL DOORS
 - LEVER HANDLES PROVIDED AT ALL PLUMBING FIXTURES
 - ALL CONTROLS, SWITCHES, OUTLETS, AND ELEC. PANEL BREAKERS ARE LOCATED PER UD REACH RANGES

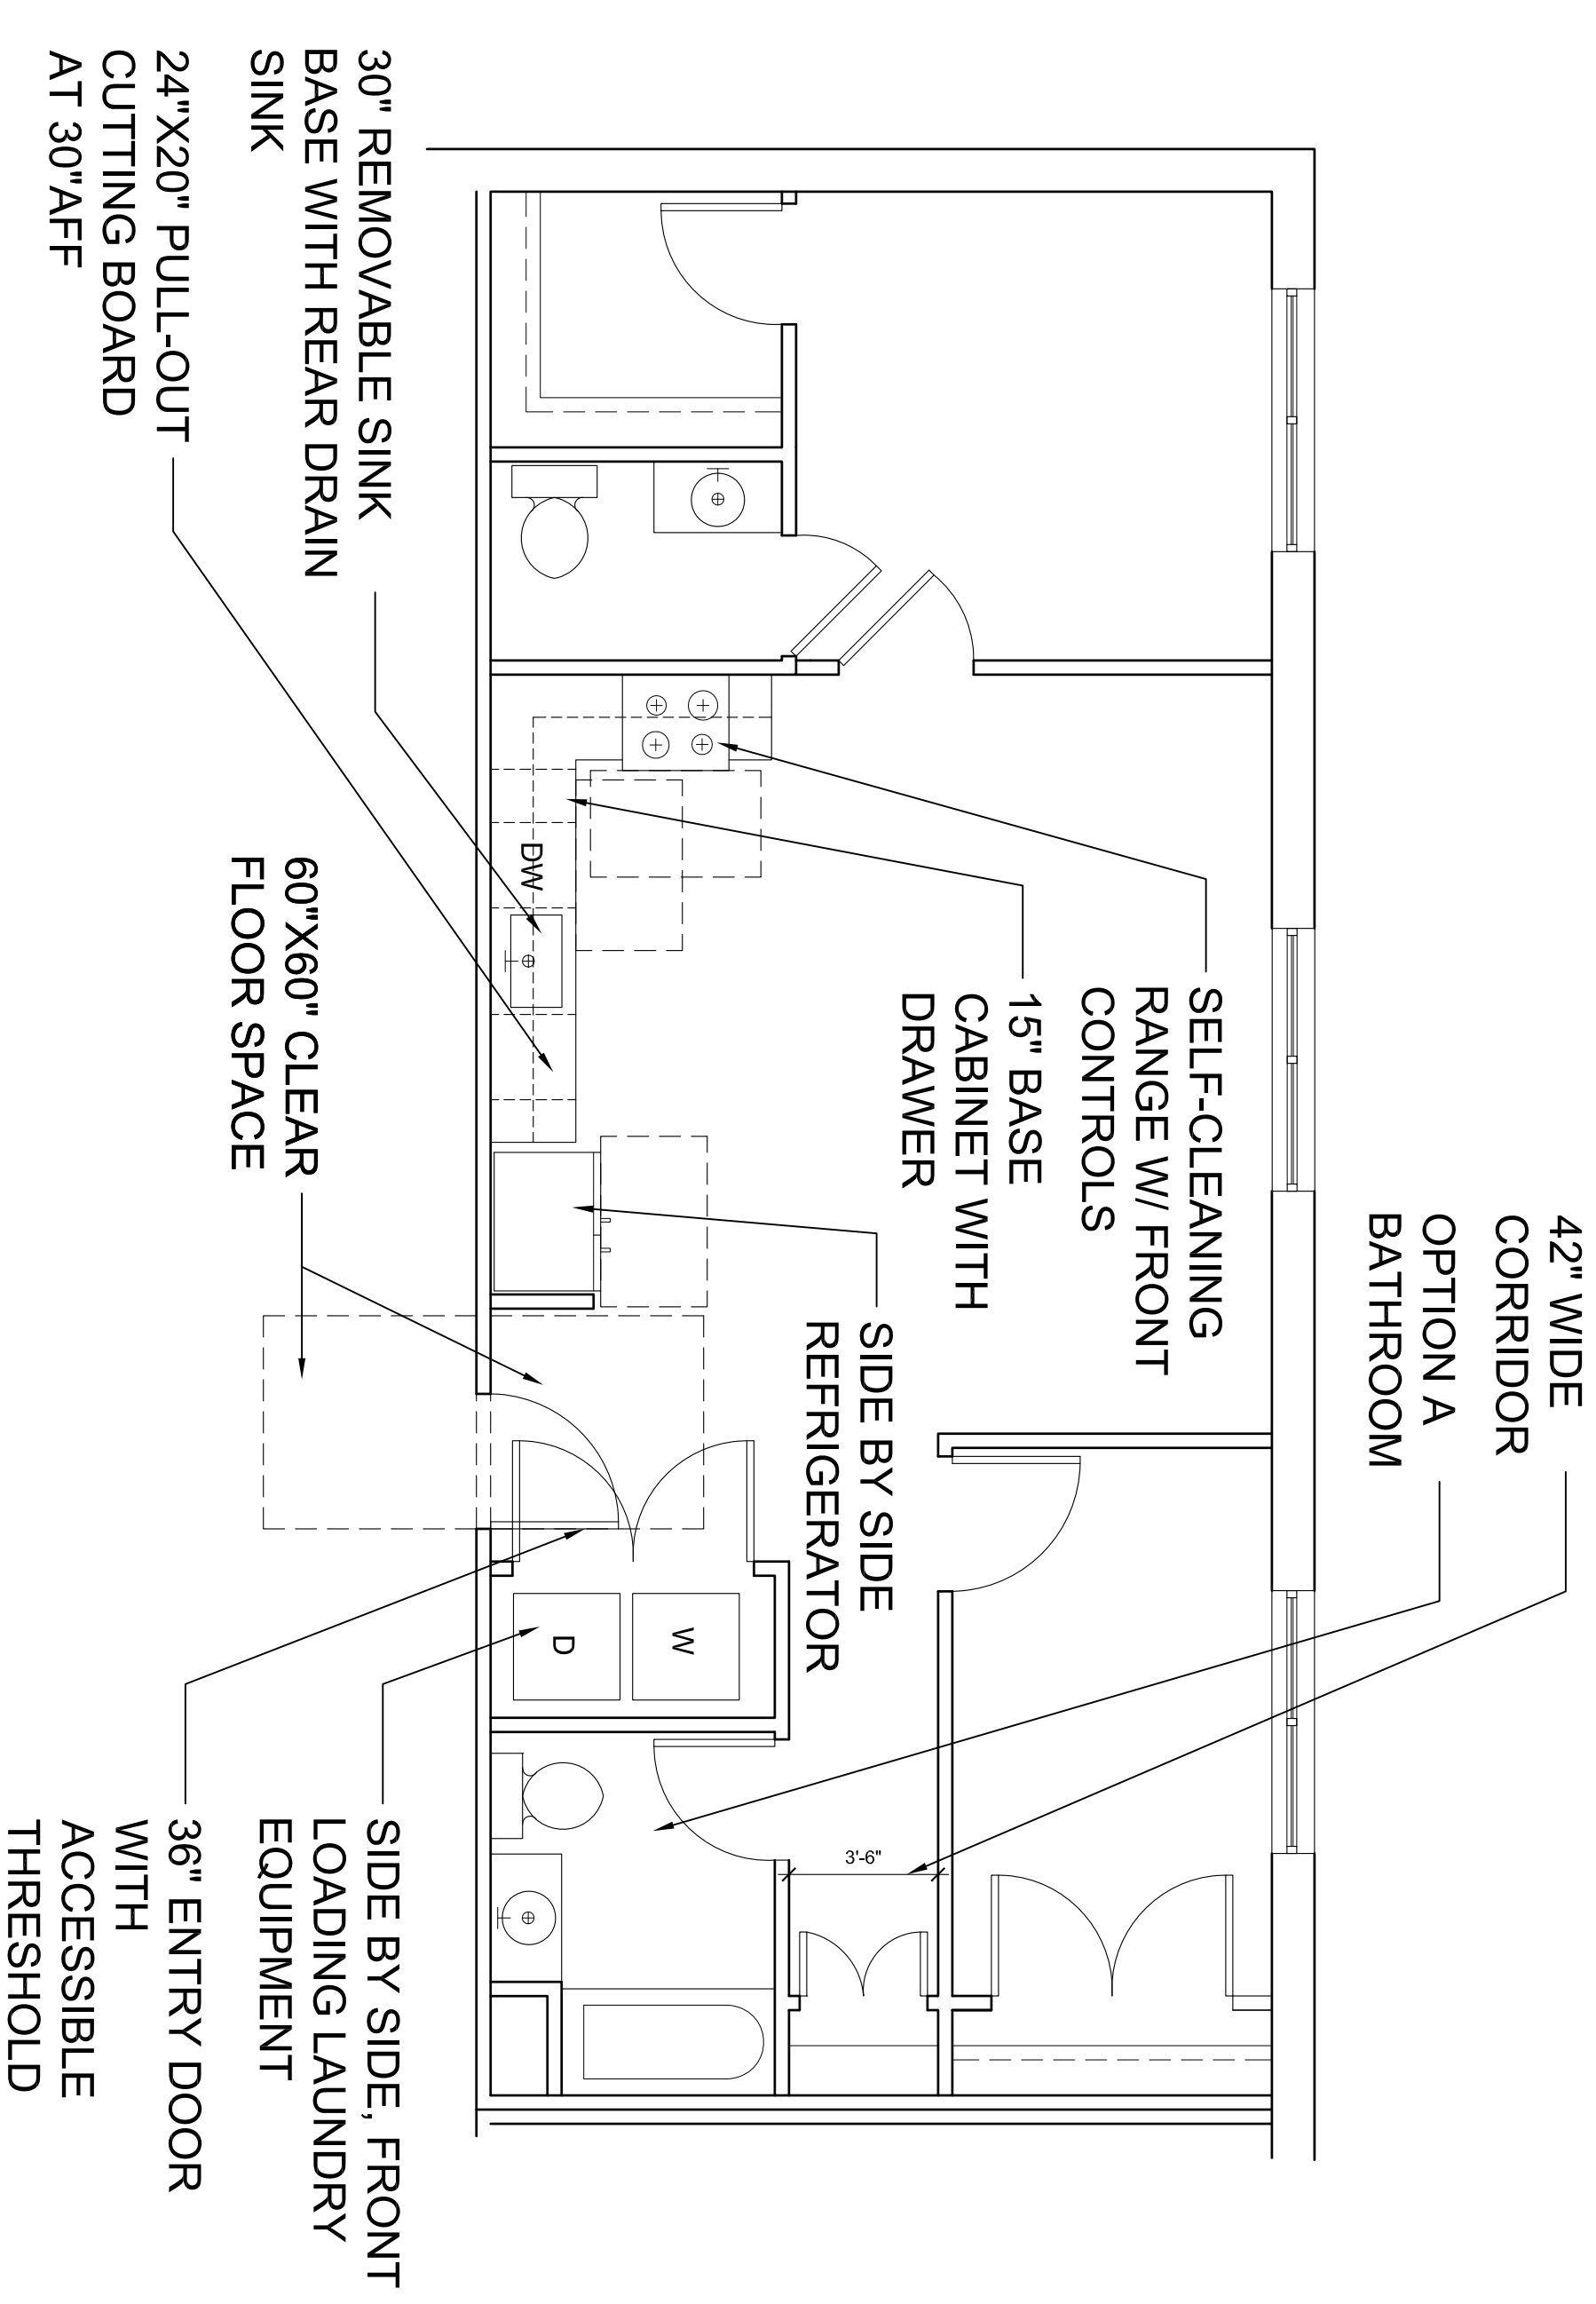

UNIVERSAL DESIGN UNIT PLAN - 2 BEDROOM

SCALE: 1/4"=1'-0"

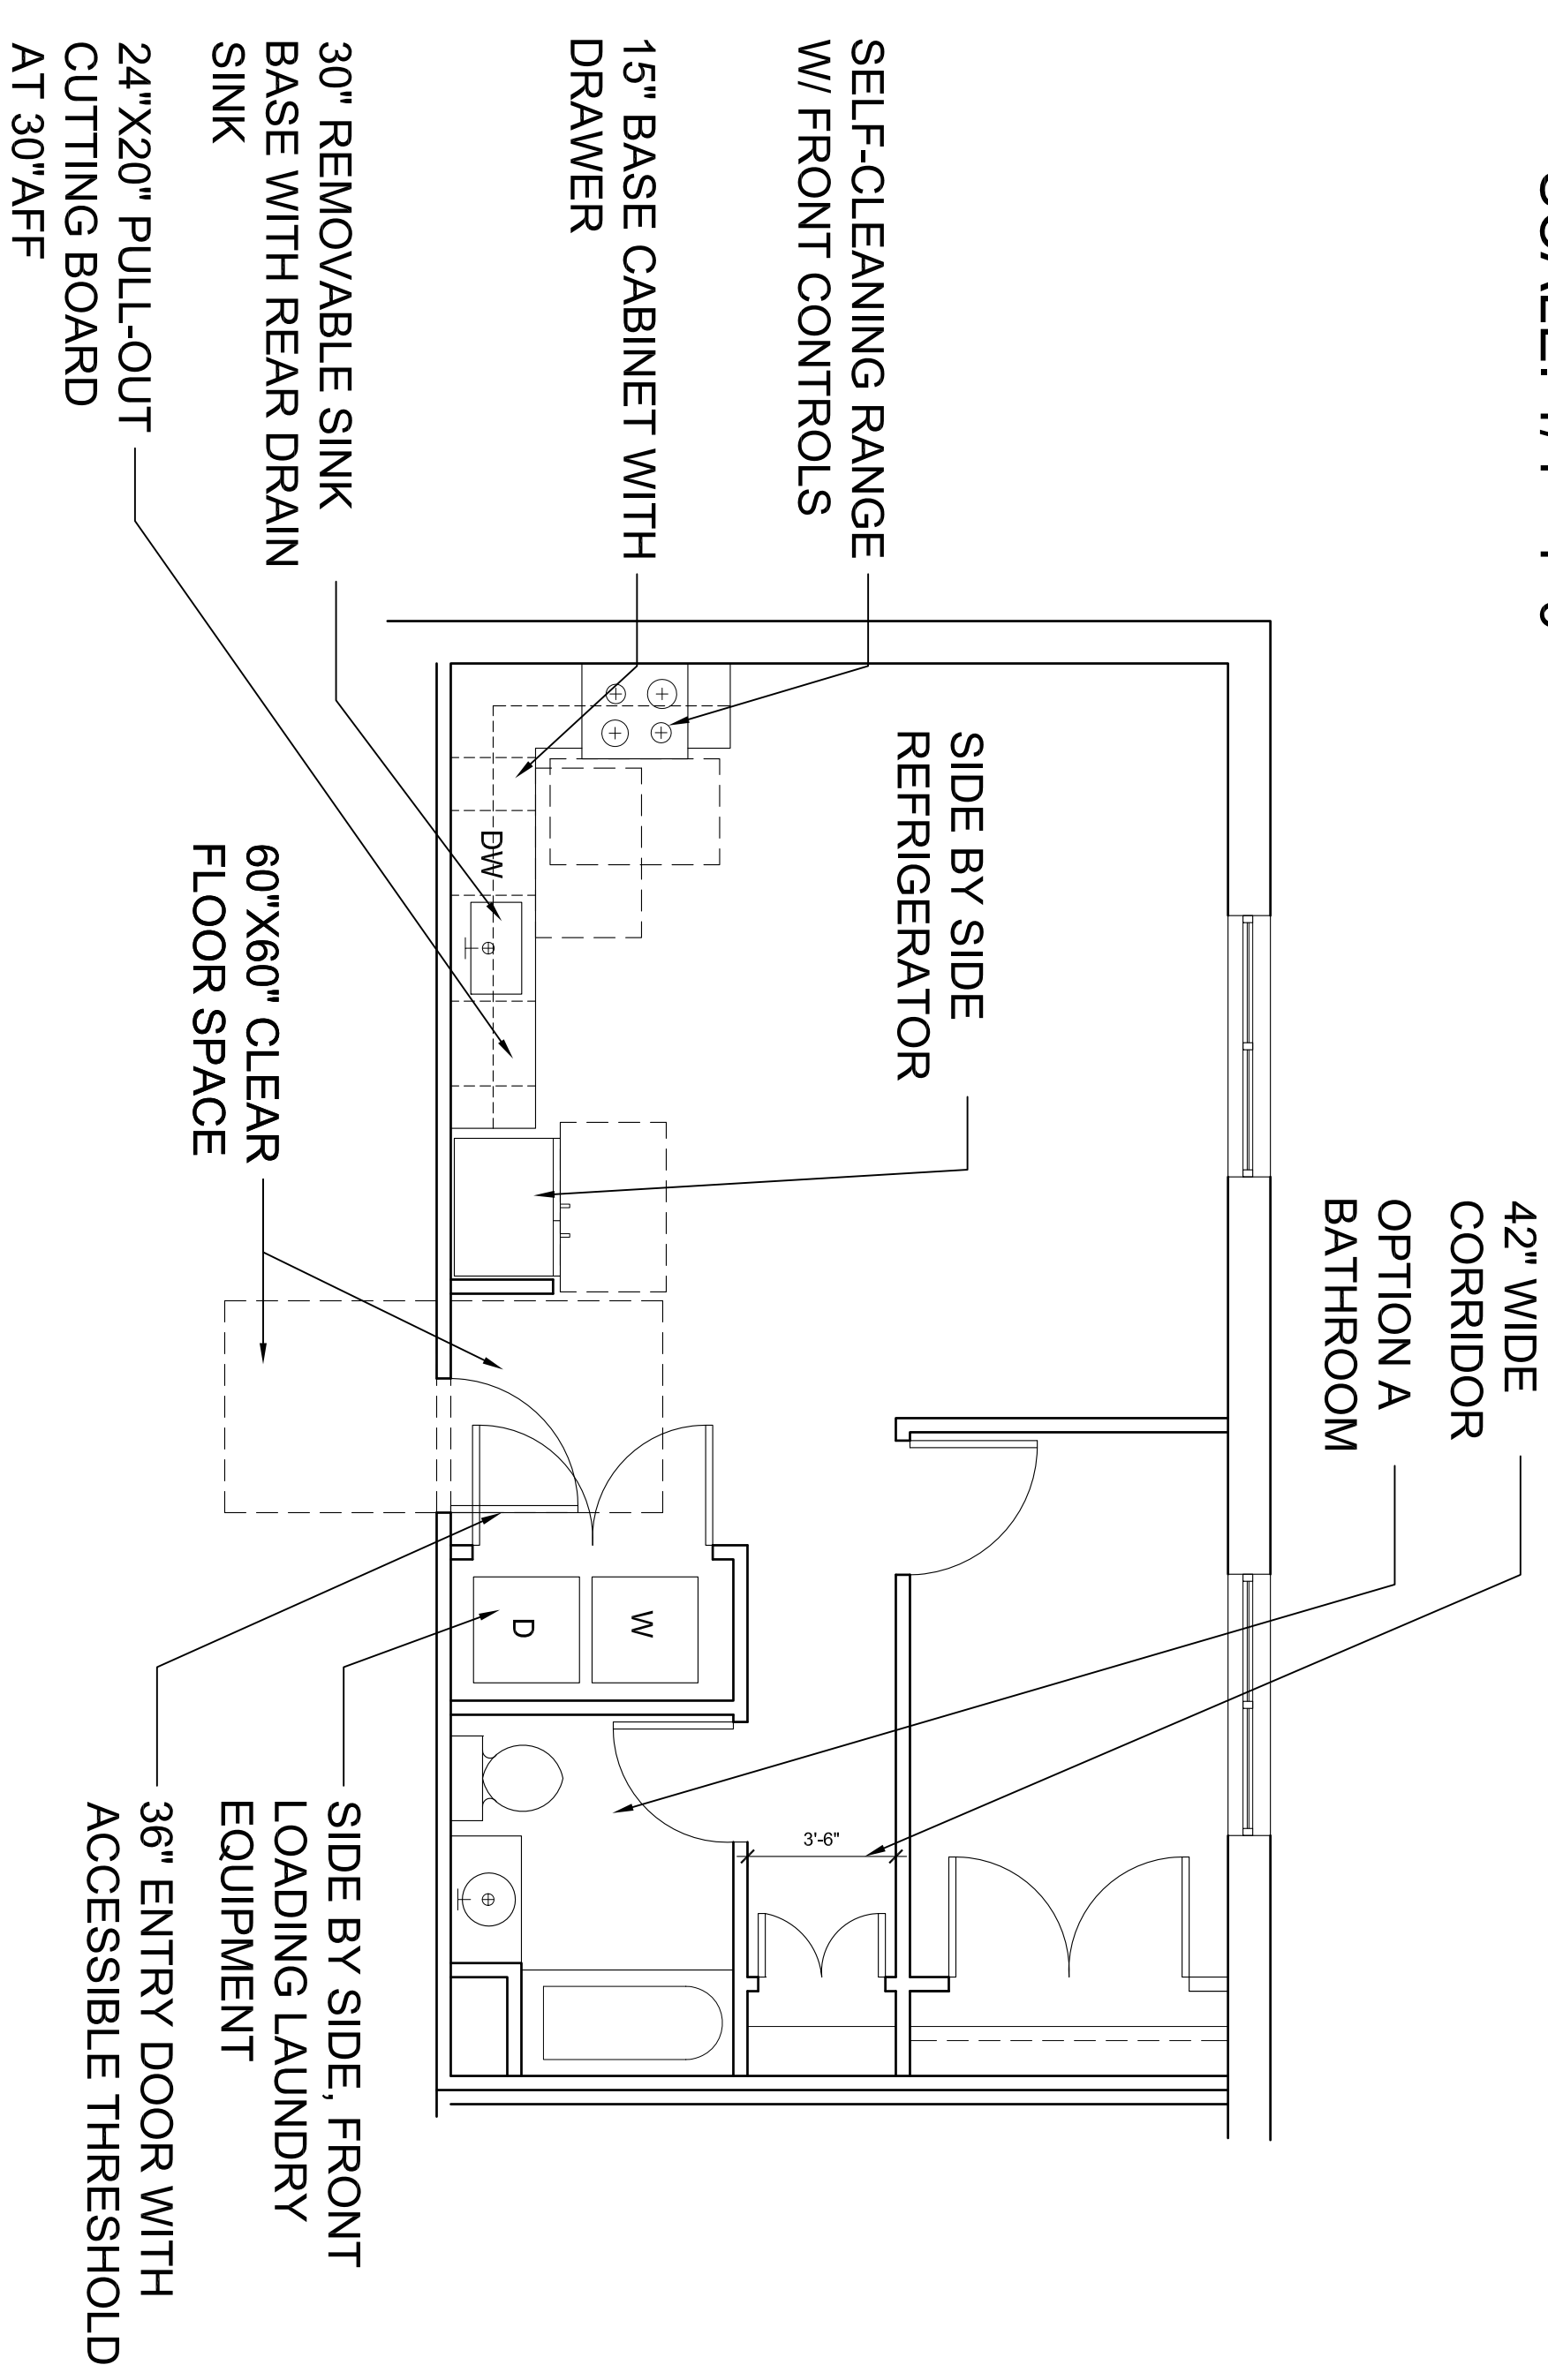

UNIVERSAL DESIGN UNIT PLAN - 1 BEDROOM

SCALE: 1/4"=1'-0"